


3~400V 50Hz

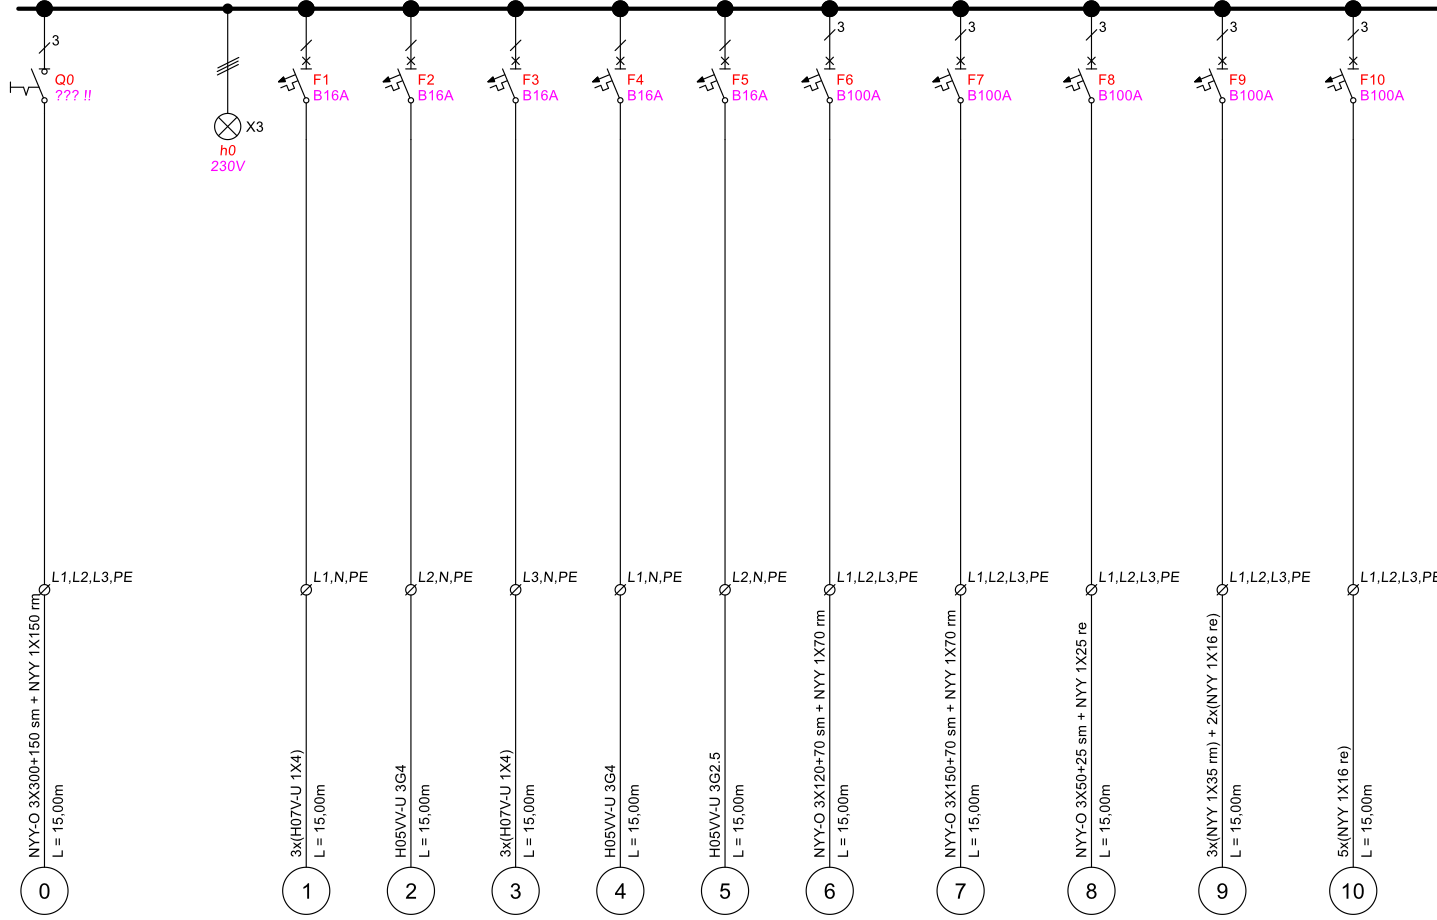

From Distribution SwitchBoard
MDB1
P = 159,00 kW

- LOAD 1 P = 3,00 kW
- LOAD 2 P = 3,00 kW
- LOAD 3 P = 3,00 kW
- LOAD 4 P = 3,00 kW
- LOAD 5 P = 3,00 kW
- LOAD 6 P = 50,00 kW
- LOAD 7 P = 50,00 kW
- LOAD 8 P = 50,00 kW
- LOAD 9 P = 50,00 kW
- LOAD 10 P = 50,00 kW

		Project		iec examples	
		Drawing title		Distribution board single-line diagram	
		Designer		DB2	
		Office		Switchboard	
		Client		Distribution board type and protection degree	
		Client		Wall mounted, IP23	
Ver.		Modification		Name	
				Date	
				Drawing Number	
				DB2	
				Sheet	
				1/1	
				Created	
				30/7/2016	
				Scale	
				-	

